



DOYLE COFFIN ARCHITECTURE

Doyle Coffin Architecture, LLC
159 Danbury Road
Ridgefield, Connecticut 06877
203 | 431 | 6001
203 | 431 | 9764 fax
info@doylecoffinarchitecture.com
doylecoffinarchitecture.com

Evans Associates
Civil Engineer
295 Amy Road
Danbury, CT 06824
203 | 353 | 0599

The DRS&M Project Group
Mechanical Engineer
63 Gage Hill Road
Ridgefield, CT 06877
203 | 438 | 9381

Kahler Roux, LLC
MEP / PE Engineer
301 Main Street
Danbury, CT 06810
203 | 783 | 0171

NOTES

KEY PLAN

NEW CHURCH
FOR
SAINT ANDREWS
LUTHERAN CHURCH
6 IVY HILL ROAD
RIDGEFIELD, CT 06877


ISSUED FOR BIDDING 03.02.12

PRINCIPAL JMD P.A. MLM
JOB # 578 SCALE 3/8" = 1'-0"
CONSTRUCTION DOCUMENTS

Floor Plan

DOYLE COFFIN ARCHITECTURE, LLC 2011
SHEET

A1.0

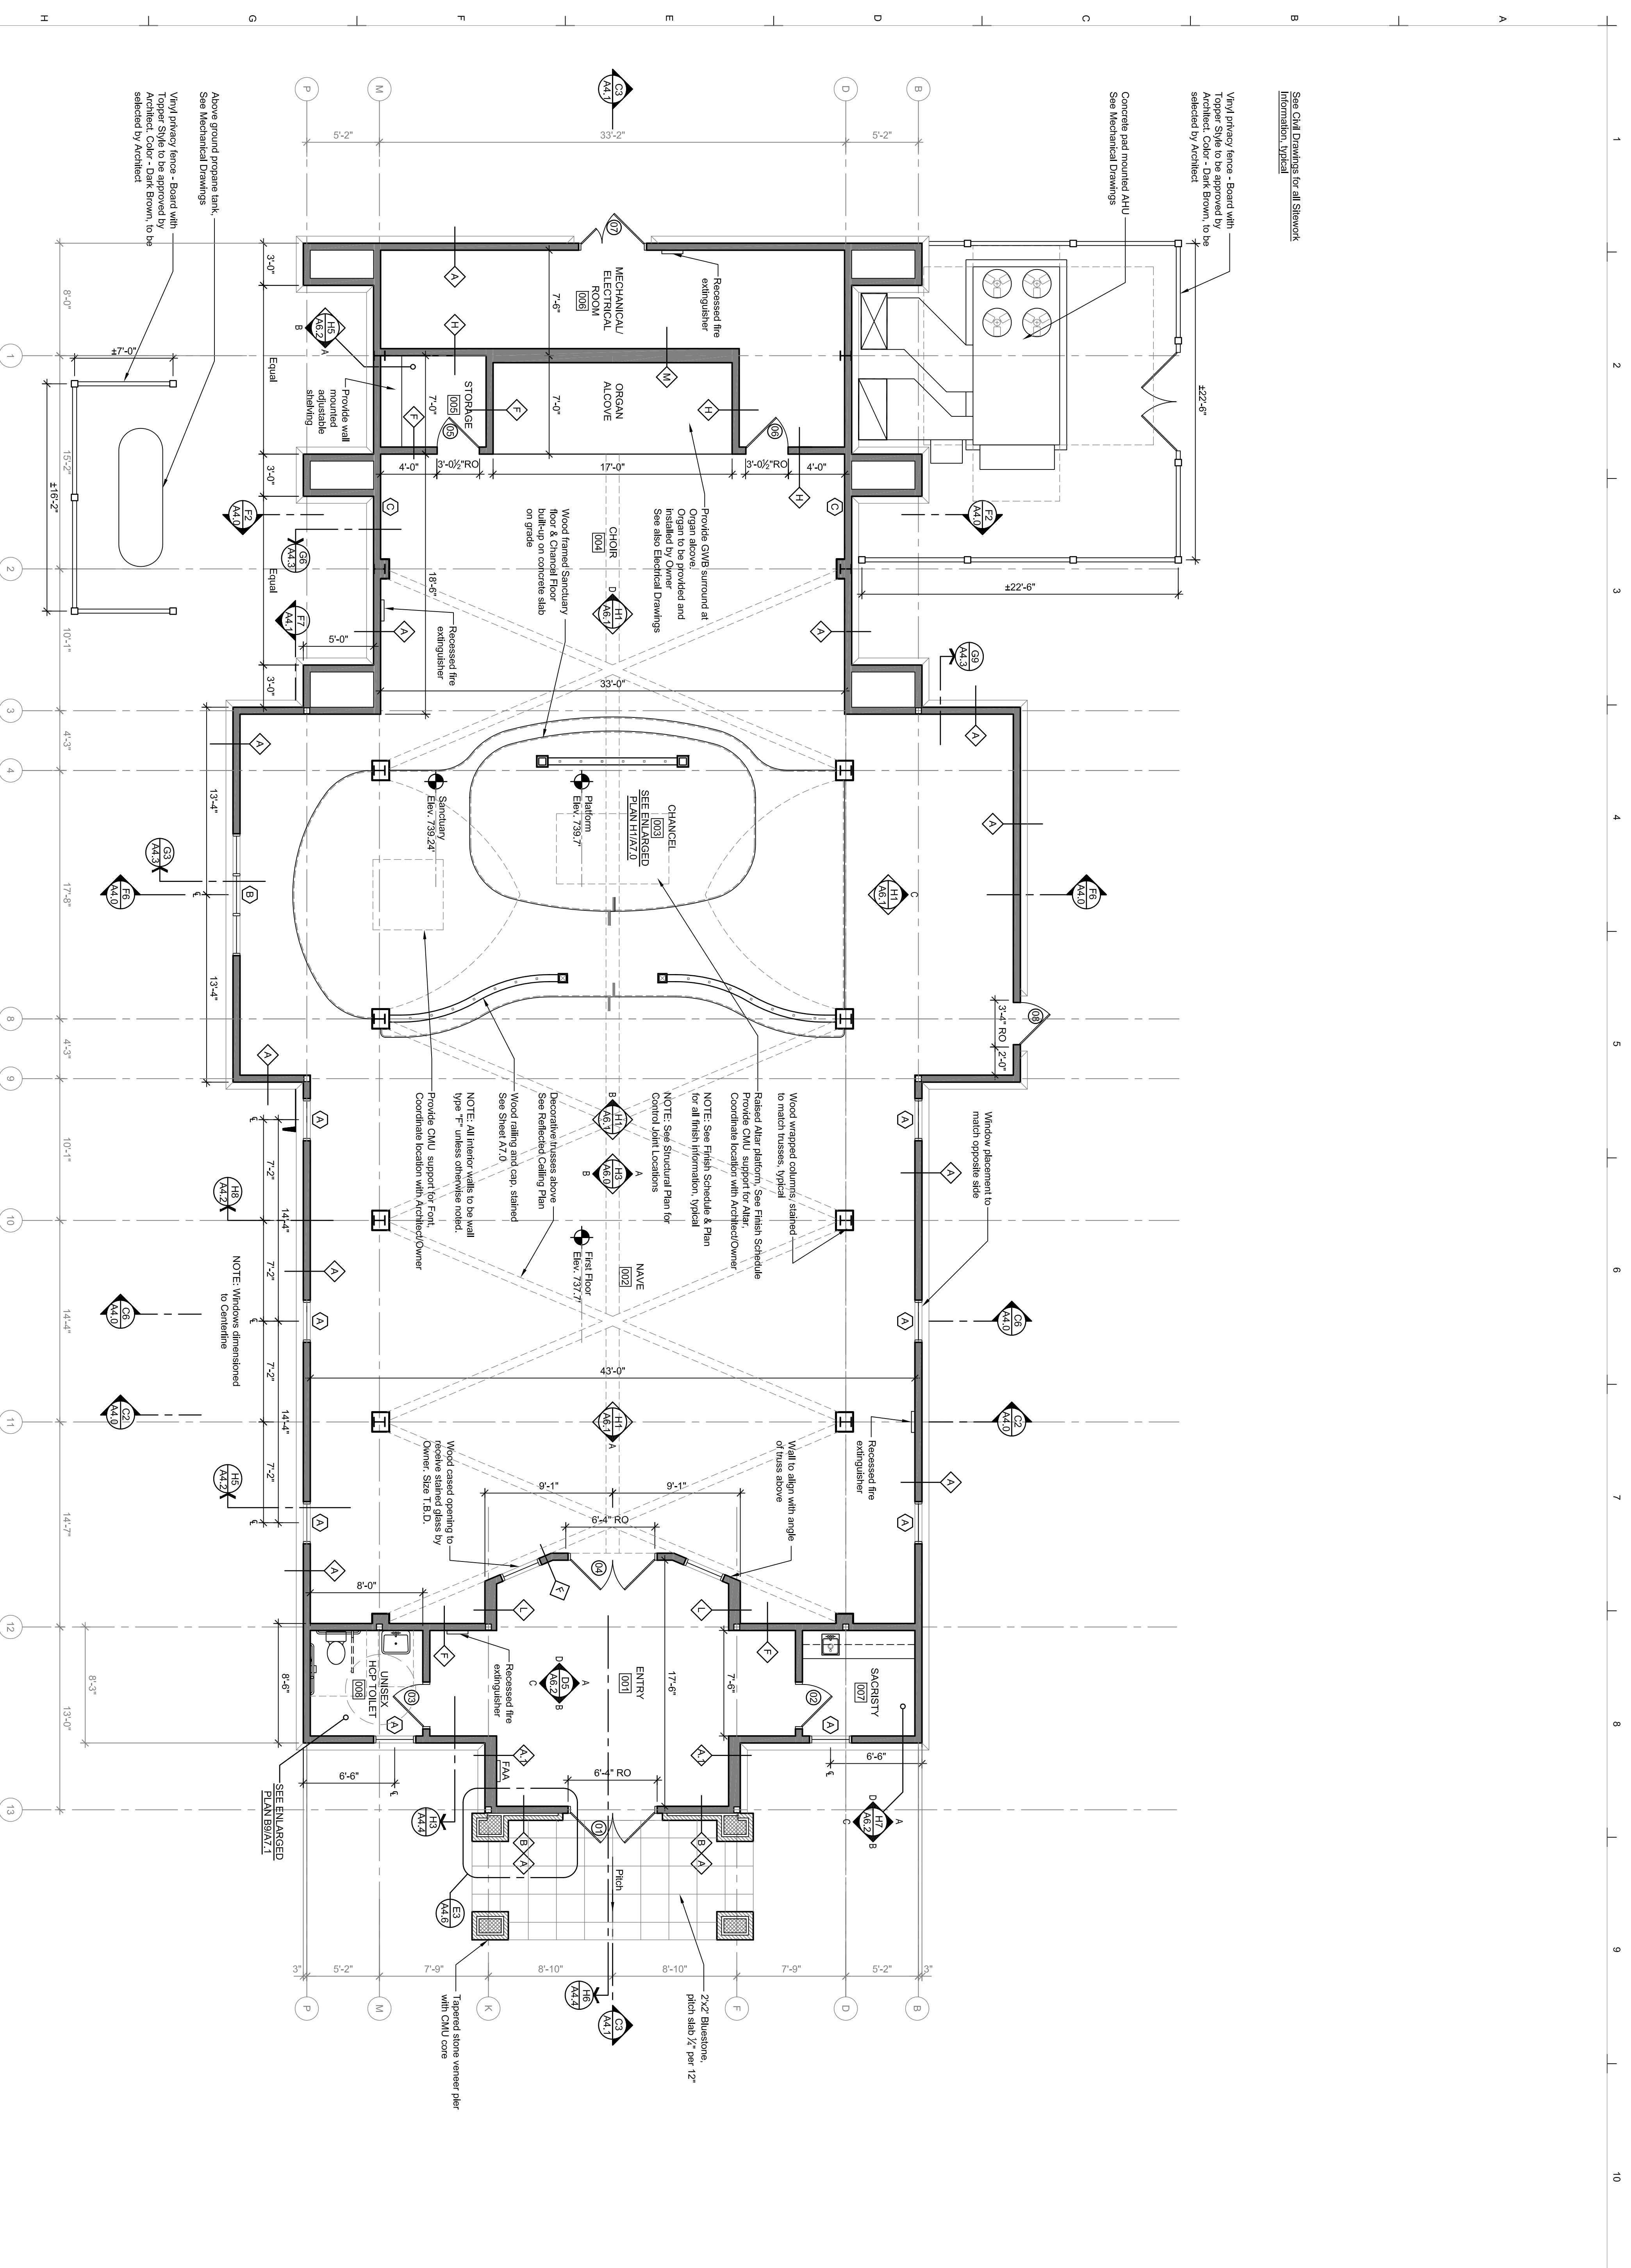

See Civil Drawings for all Sitemap Information, Typical

Vinyl privacy fence - Board with Topper Style to be approved by Architect. Color - Dark Brown, to be selected by Architect.

Concrete pad mounted AHU See Mechanical Drawings

Above ground propane tank. See Mechanical Drawings
Vinyl privacy fence - Board with Topper Style to be approved by Architect. Color - Dark Brown, to be selected by Architect.